



PART BOILER RM PLAN

LEGEND
 HW-5 HOT WATER SUPPLY
 HW-6 HOT WATER RETURN
 CNTR COND NEW TO EXIST
 EX- EXHAUST CRIBLE
 S.E. SUPPLY REGISTER
 R-6 RETURN GRILLE

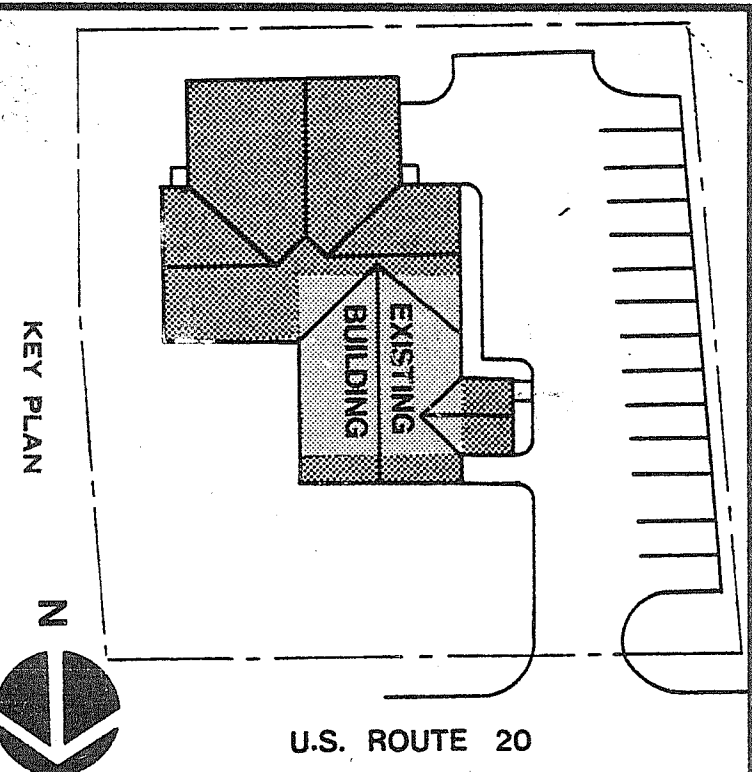

REV. NO.	DESCRIPTION	DATE	BY

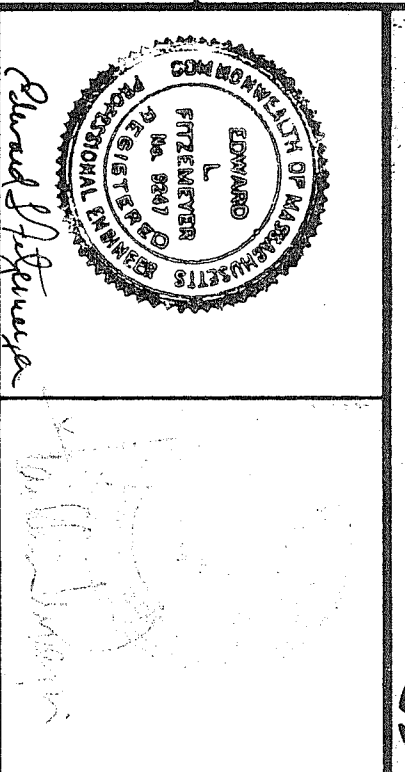

ALTERATIONS & ADDITIONS
 POLICE STATION
 SUBBURY, MASS.

KUBITZ & PEPI
 ARCHITECTS, INC.
 66 CENTRAL STREET WILMINGTON, MASS.

FLOOR PLAN

SCALE 1/4" = 1'-0"	CONTRACT
DATE FILE 05/19/00	DRAWING NO.
DR BY	
CM BY	
SHEET 22 OF 23	

H1

