


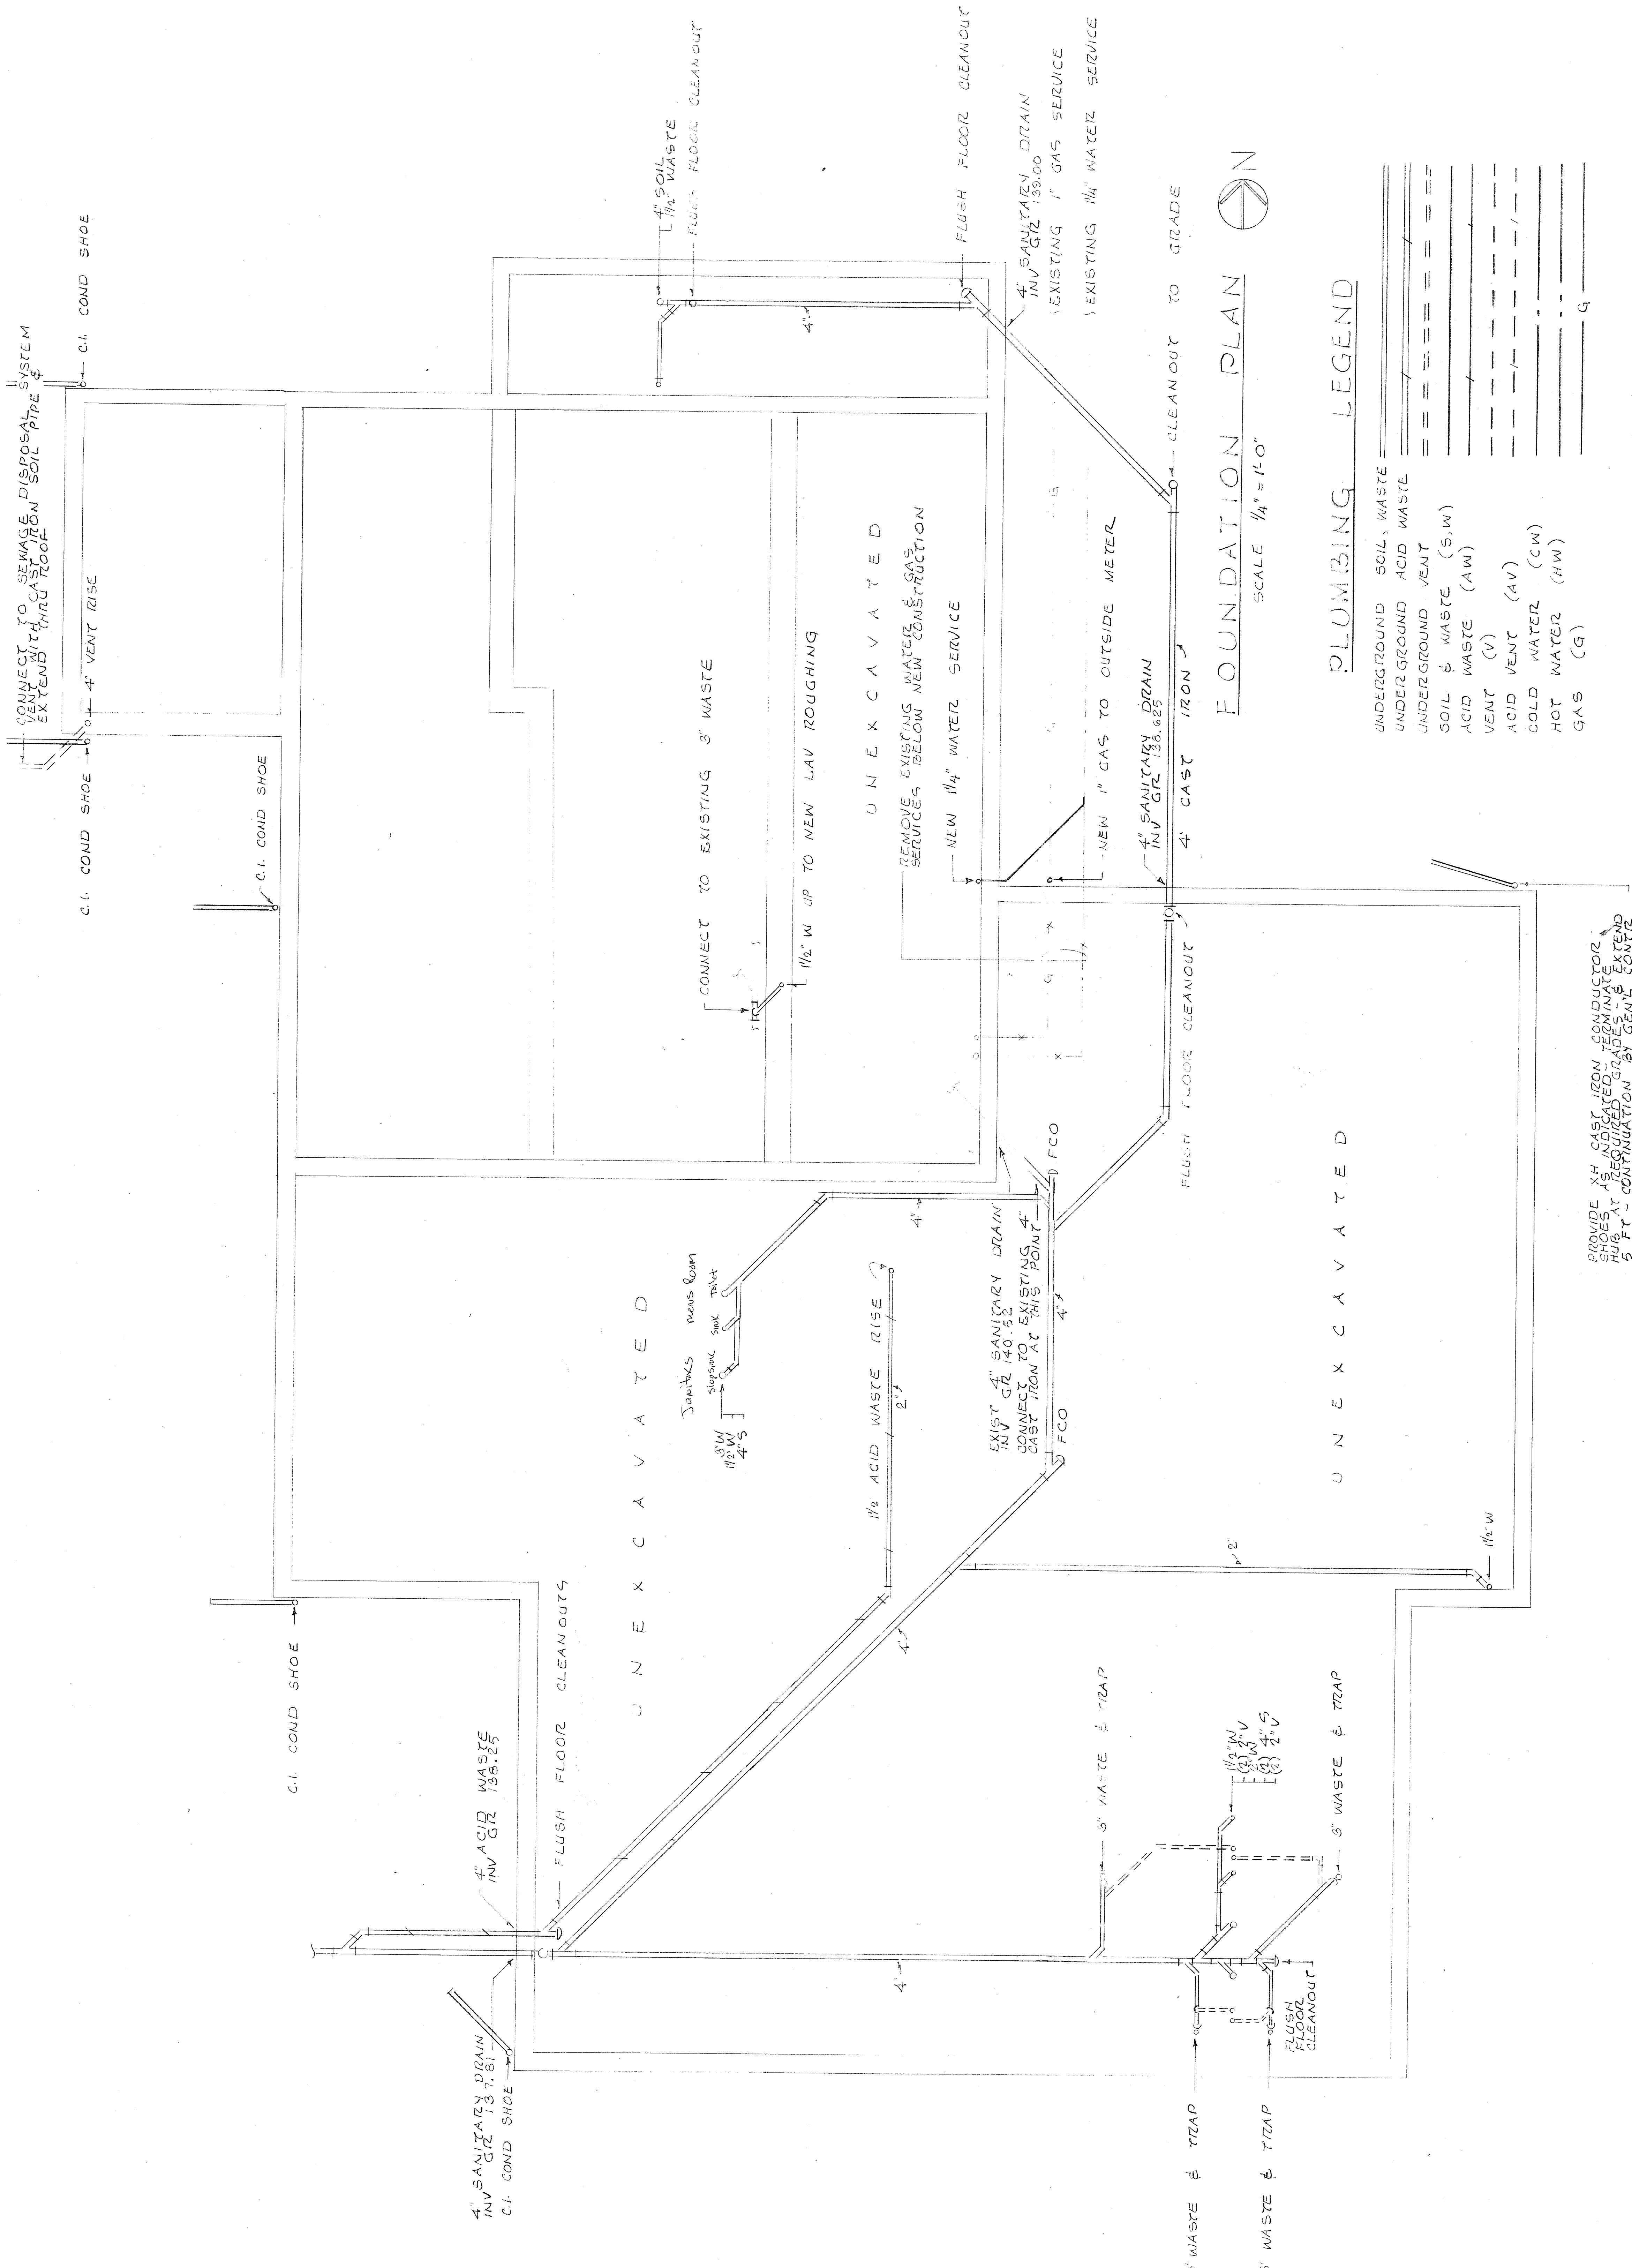



FOUNDATION PLAN
SCALE 1/4" = 1'-0"

PLUMBING LEGEND

UNDERGROUND	SOIL, WASTE
UNDERGROUND	ACID WASTE
UNDERGROUND	VENT
SOIL & WASTE (S.W)	
ACID WASTE (AW)	
VENT (V)	
ACID VENT (AV)	
COLD WATER (CW)	
HOT WATER (HW)	
GAS (G)	

PROVIDE XH CAST IRON CONDUCTOR SHOES AS INDICATED - TERMINATE HUB AT REQUIRED GRADES - & EXTEND 5 FT - CONTINUATION BY GENE CONT

REV. NO.	DESCRIPTION	DATE	BY

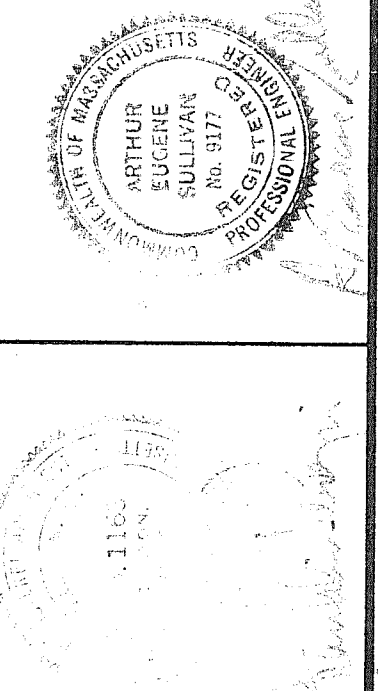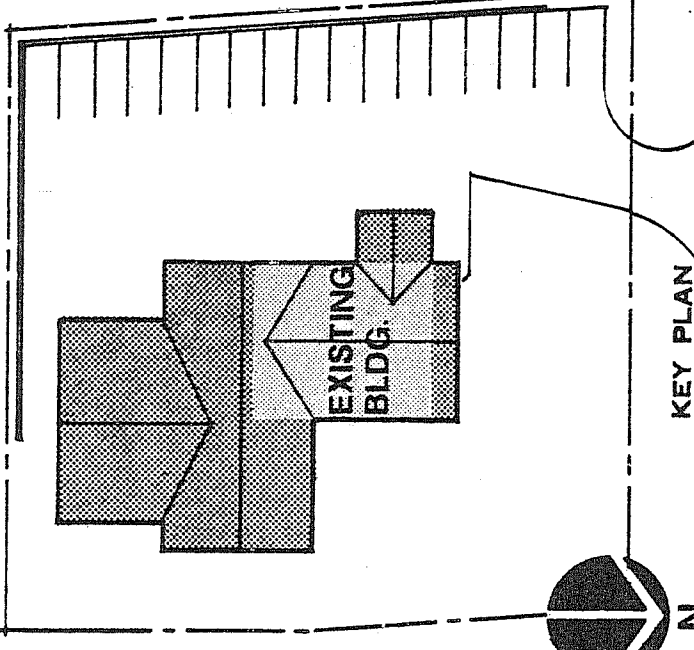

ALTERATIONS & ADDITIONS
POLICE STATION
SUDBURY, MASS.


KUBITZ & PEPI
ARCHITECTS INC.
66 CENTRAL STREET WELLESLEY, MASS.

FOUNDATION PLAN

SCALE	1/4" = 1'-0"	CONTRACT
DATE	AUG 28, 1980	DRAWING NO
DR BY	RLH	
CH BY	E.P.B.	
SHEET	19 OF 28	


P1

1. CONTRACTOR VERIFY ALL DIMENSIONS AT BUILDING

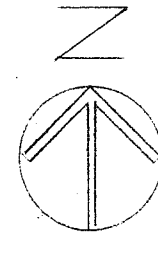


FLOOR PLAN

SCALE $1/4" = 1'-0"$

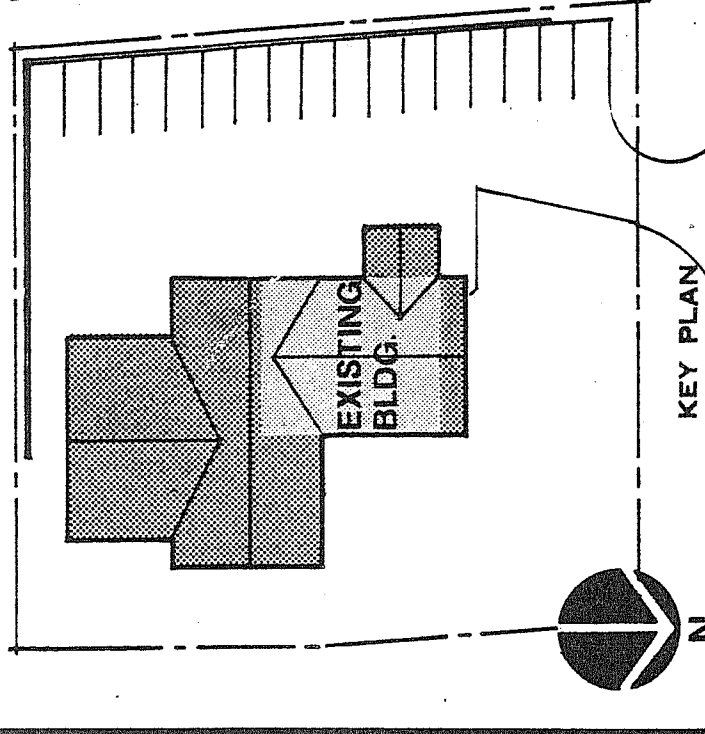

2


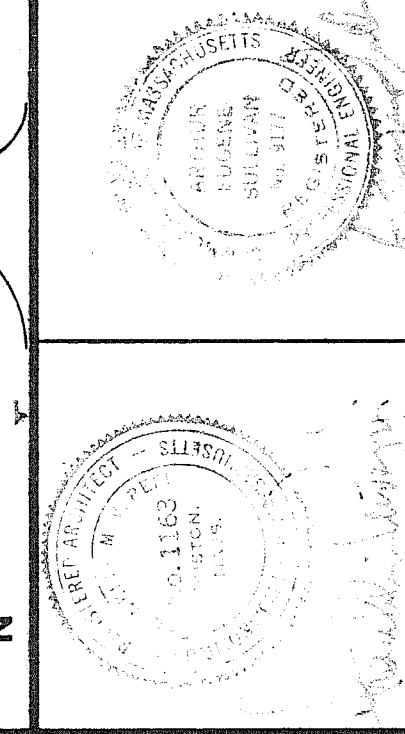


**ALTERATIONS & ADDITIONS
POLICE STATION
SUDBURY, MASS.**

KUBITZ & PEPI
ARCHITECTS INC.
- 66 CENTRAL STREET WELLESLEY MASS.

FLOOR PLAN

SCALE 1/4" = 1'-0"	CONTRACT
DATE AUG 28, 1980	DRAWING NO.
DR BY R.L.H.	P2
CH BY E.F.B.	
SHEET 20 OF 28	

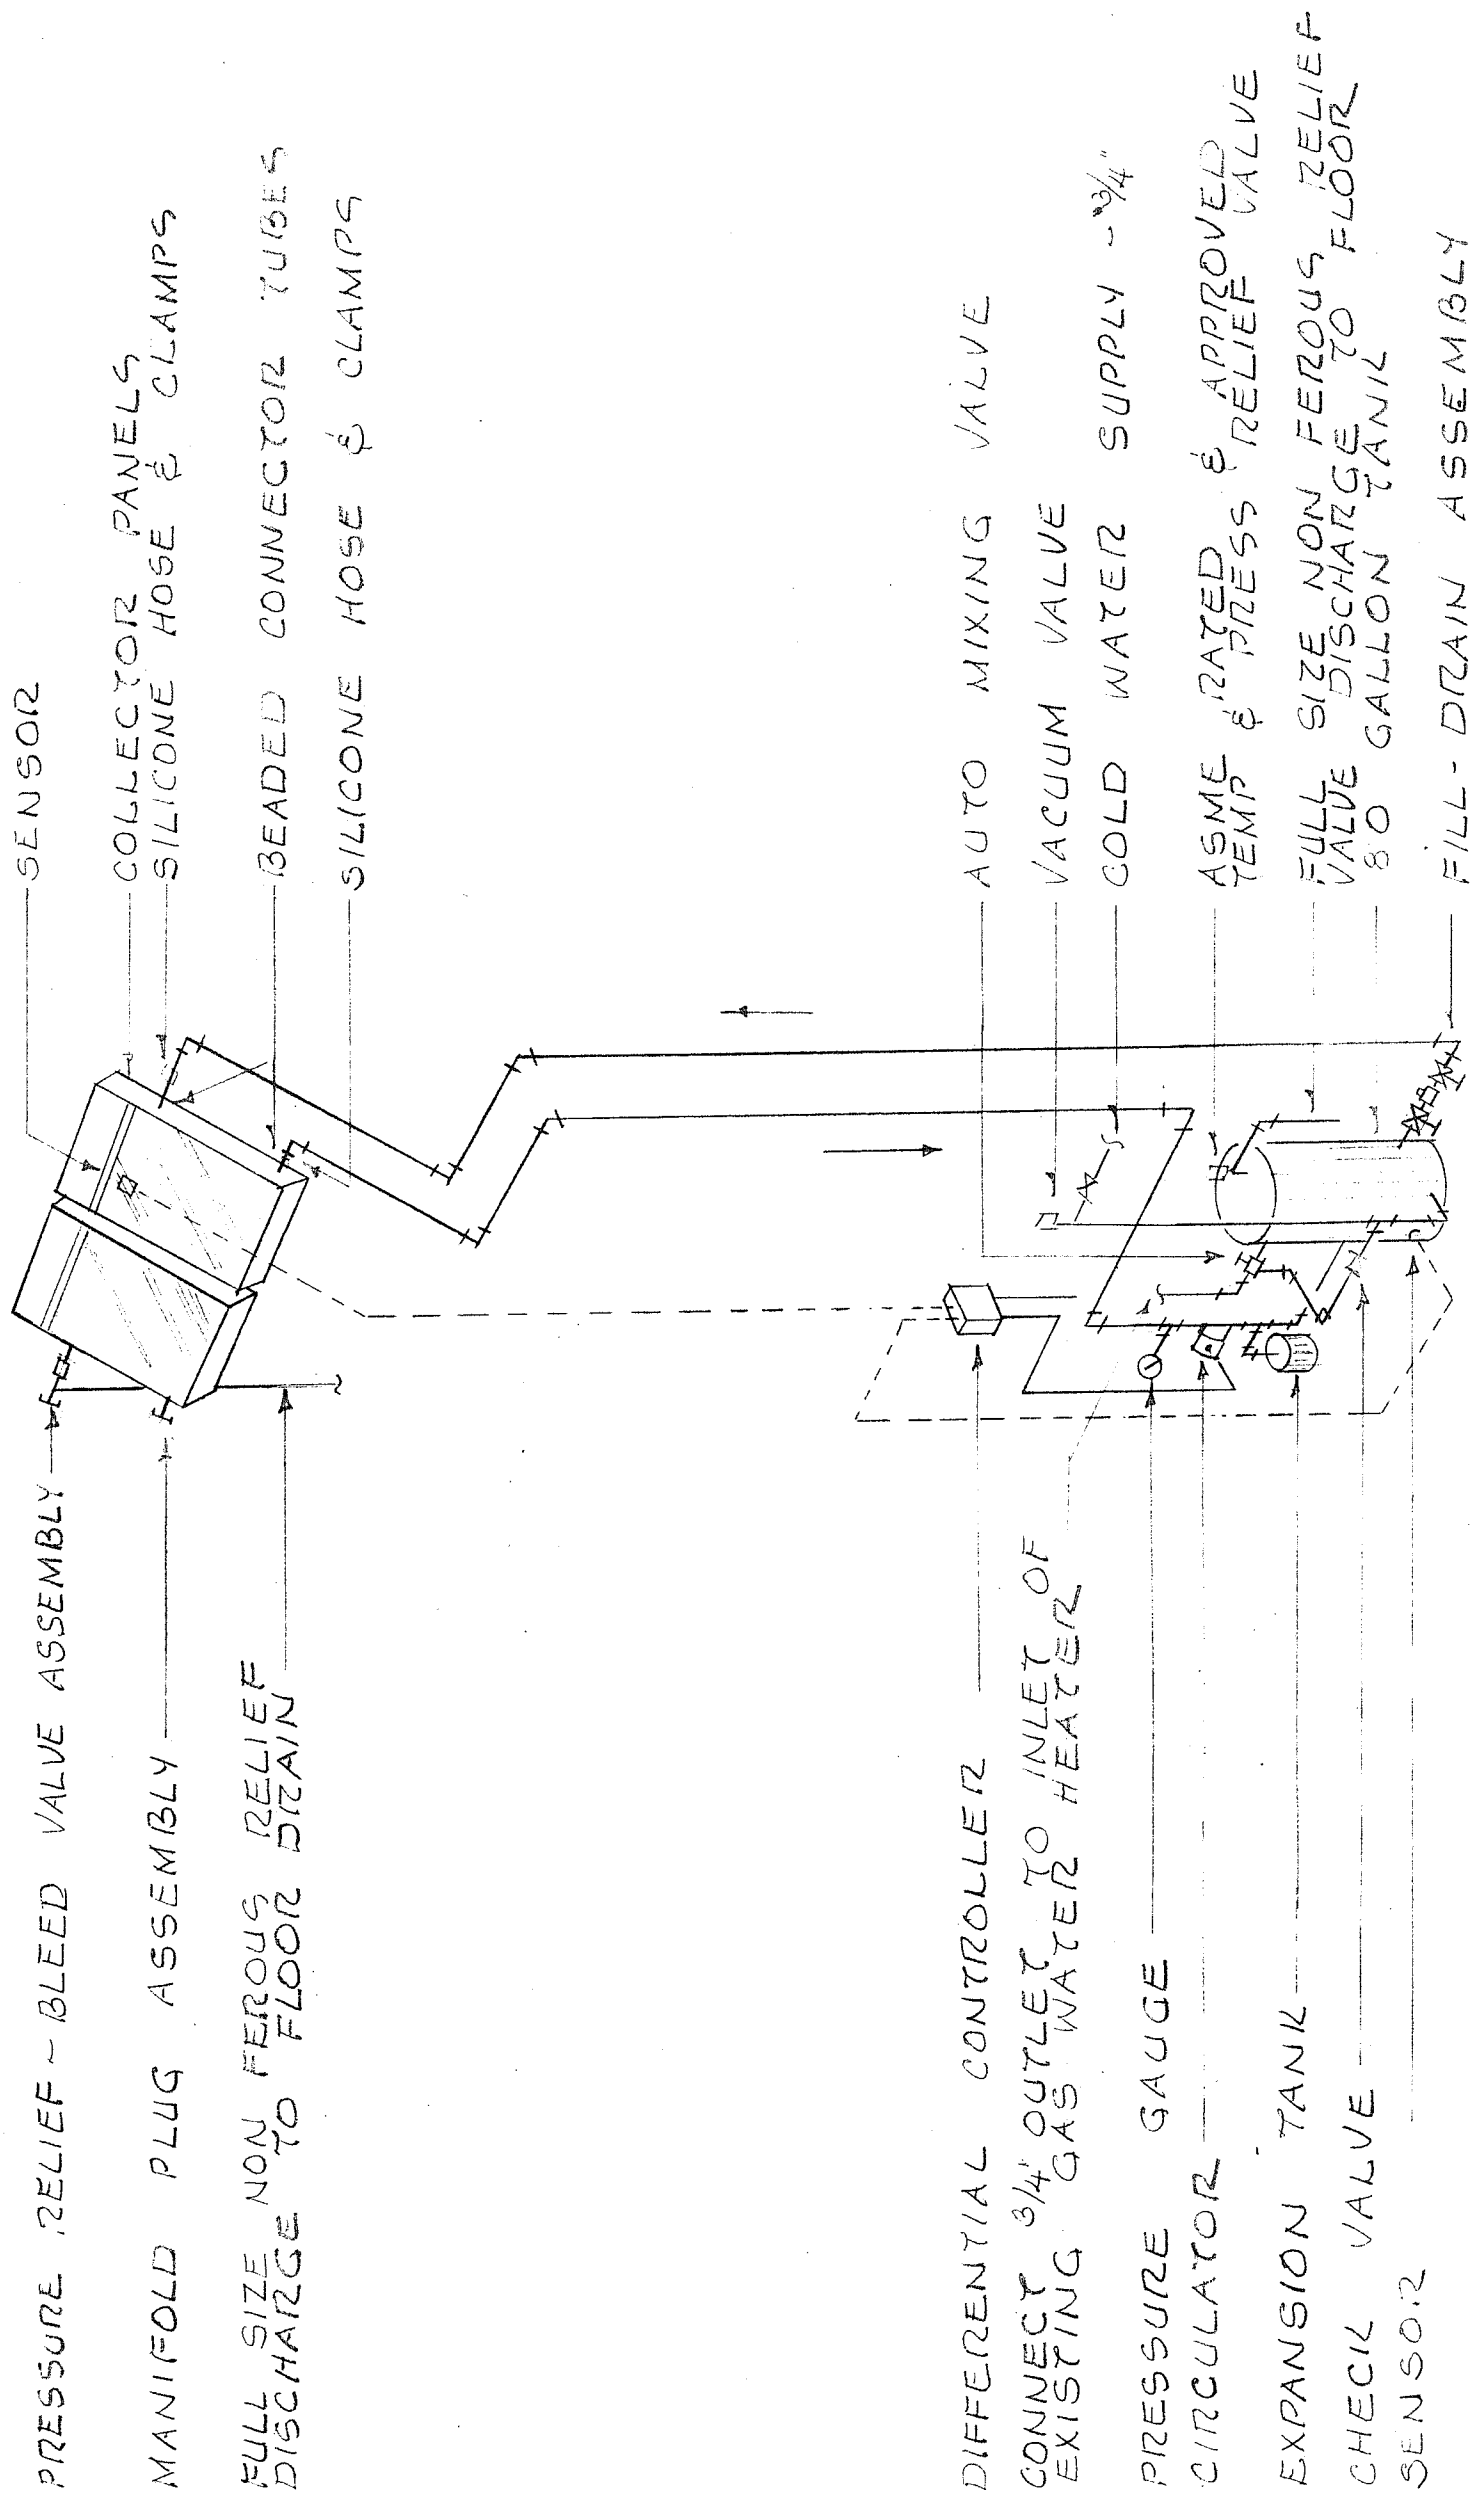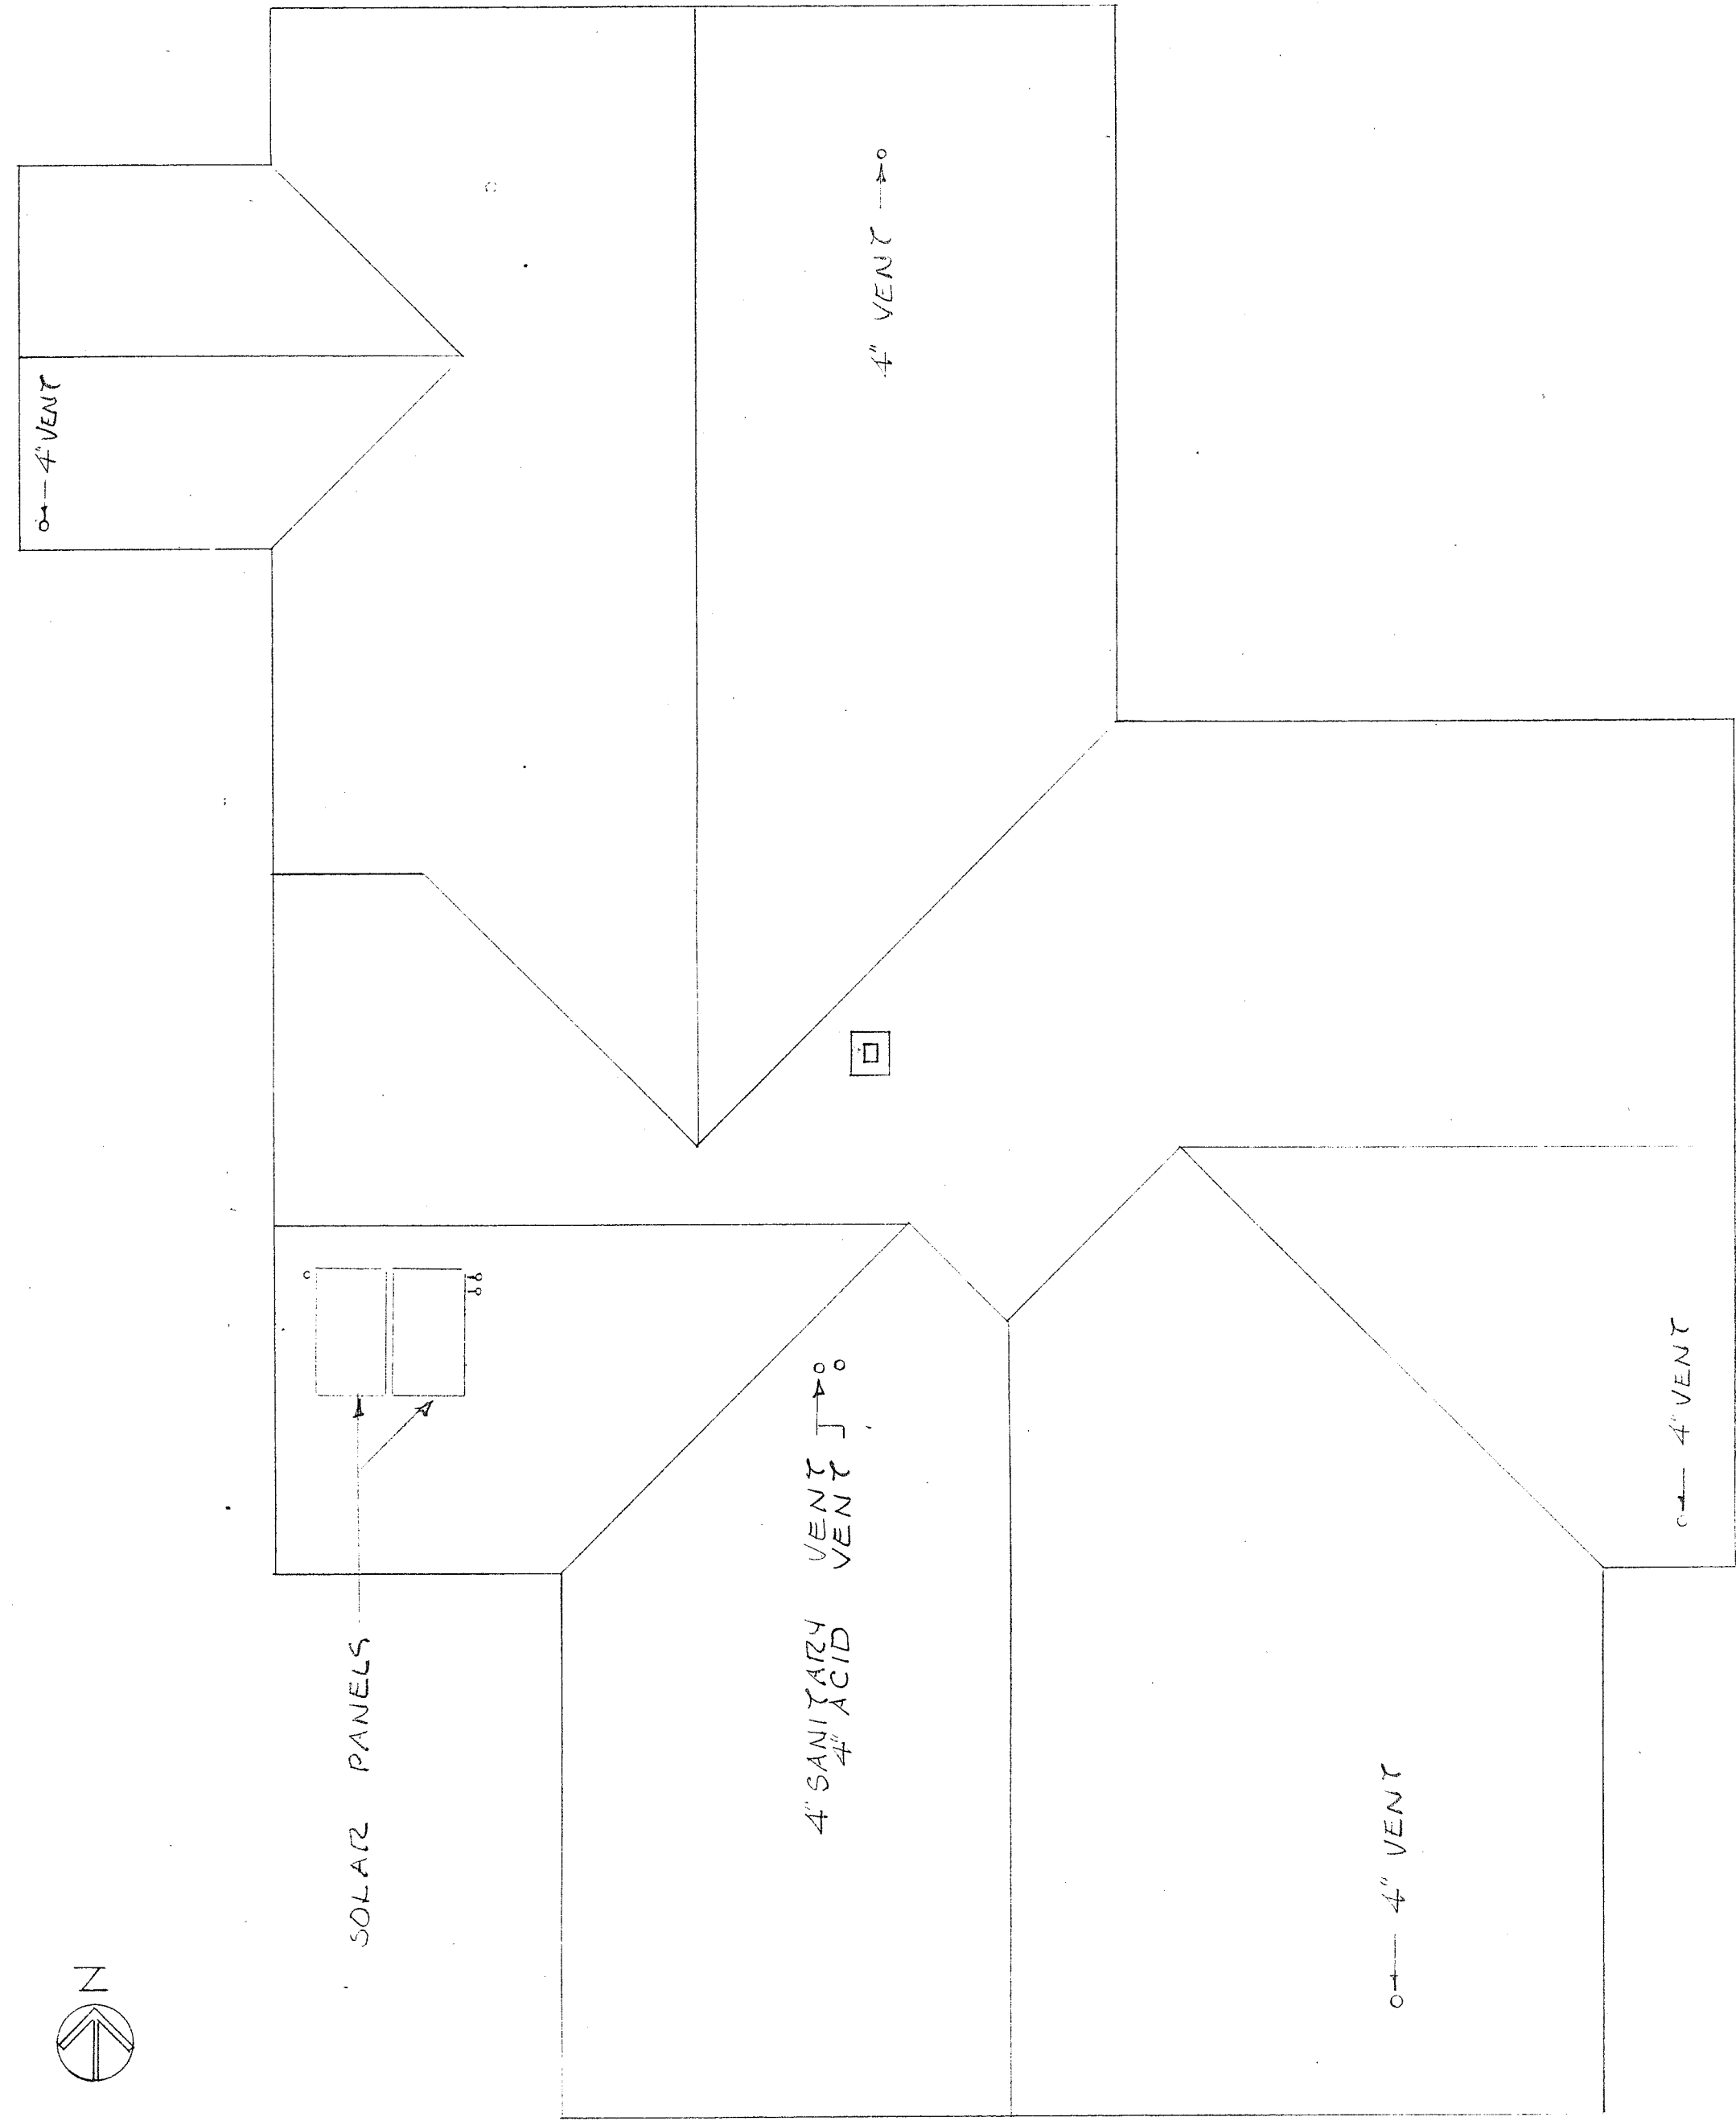


DETAIL OF SOLAR WATER HEATING SYSTEM

NO SCALE

ROOF PLAN


SCALE 1/8"=1'-0"

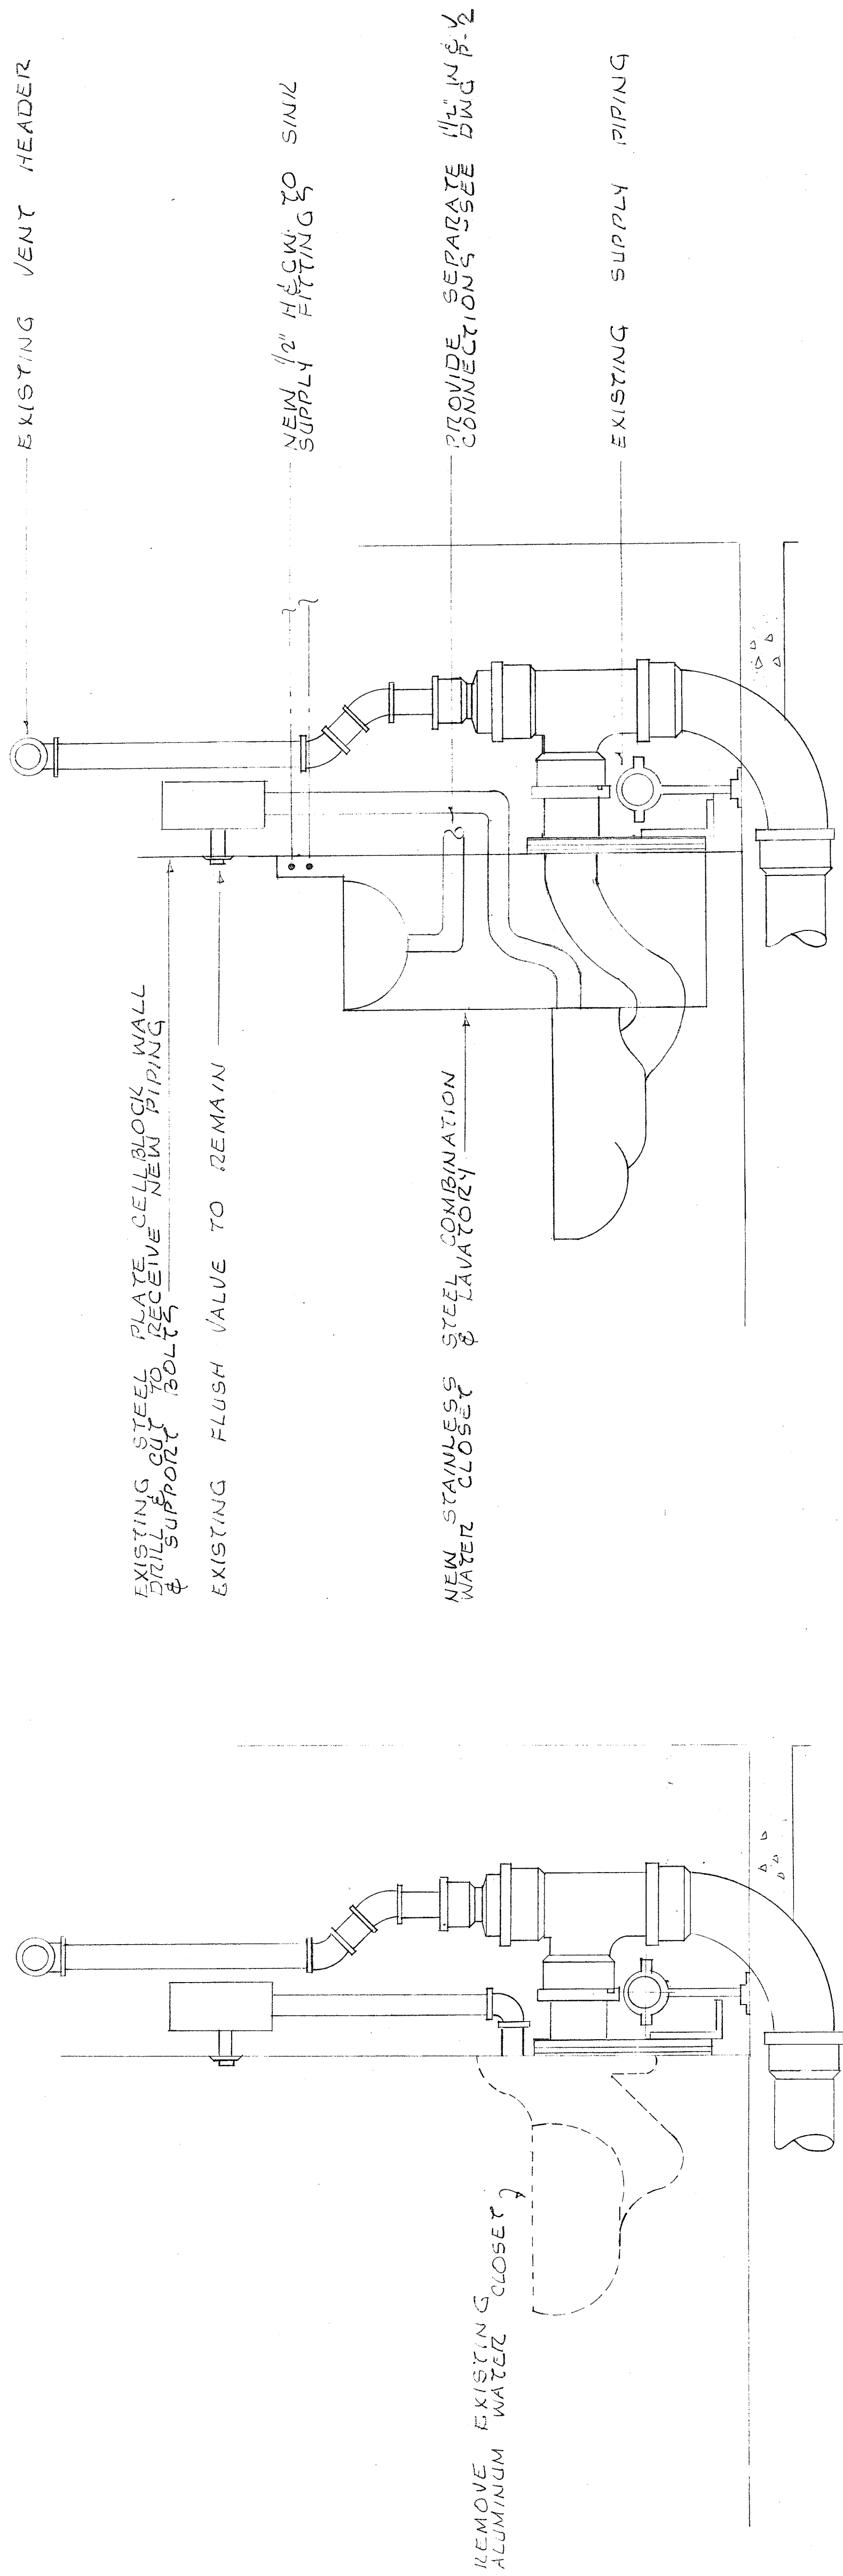


DETAILS OF NEW CELL FIXTURE INSTALLATION

SCALE 1/2"=1'-0"


(ALTERNATE No 2.)

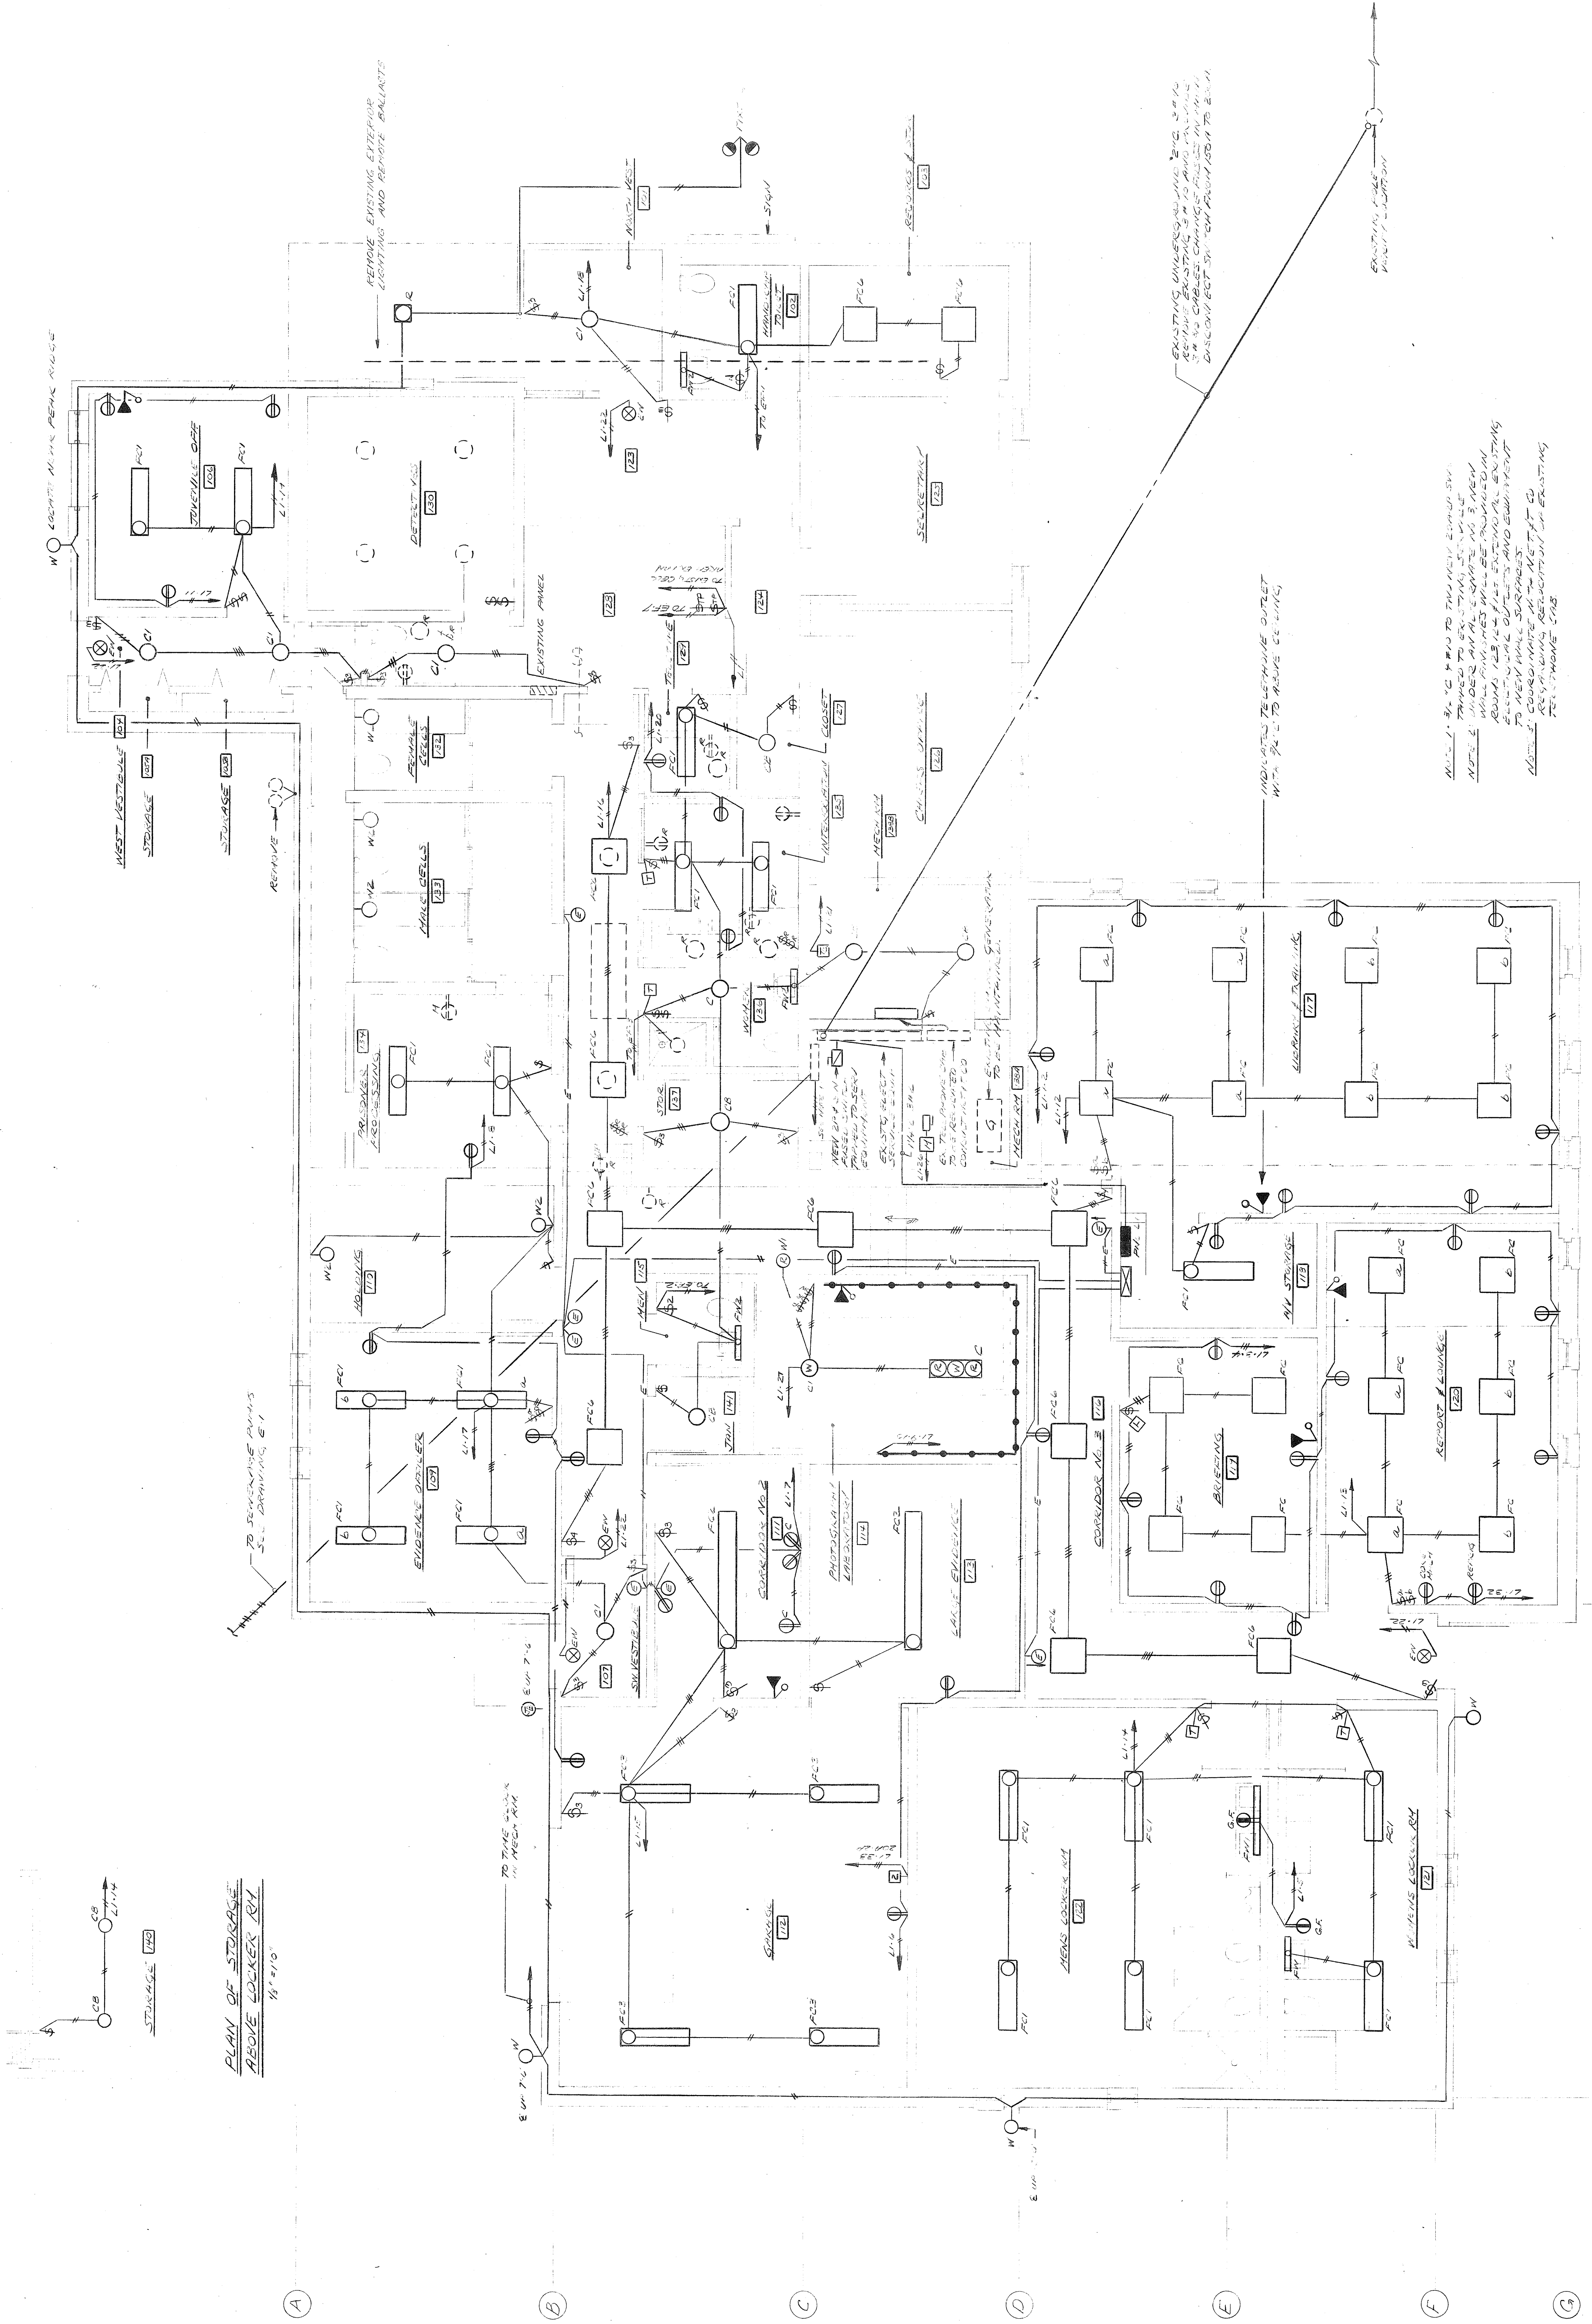


1. CONTRACTOR VERIFY ALL DIMENSIONS AT BUILDING

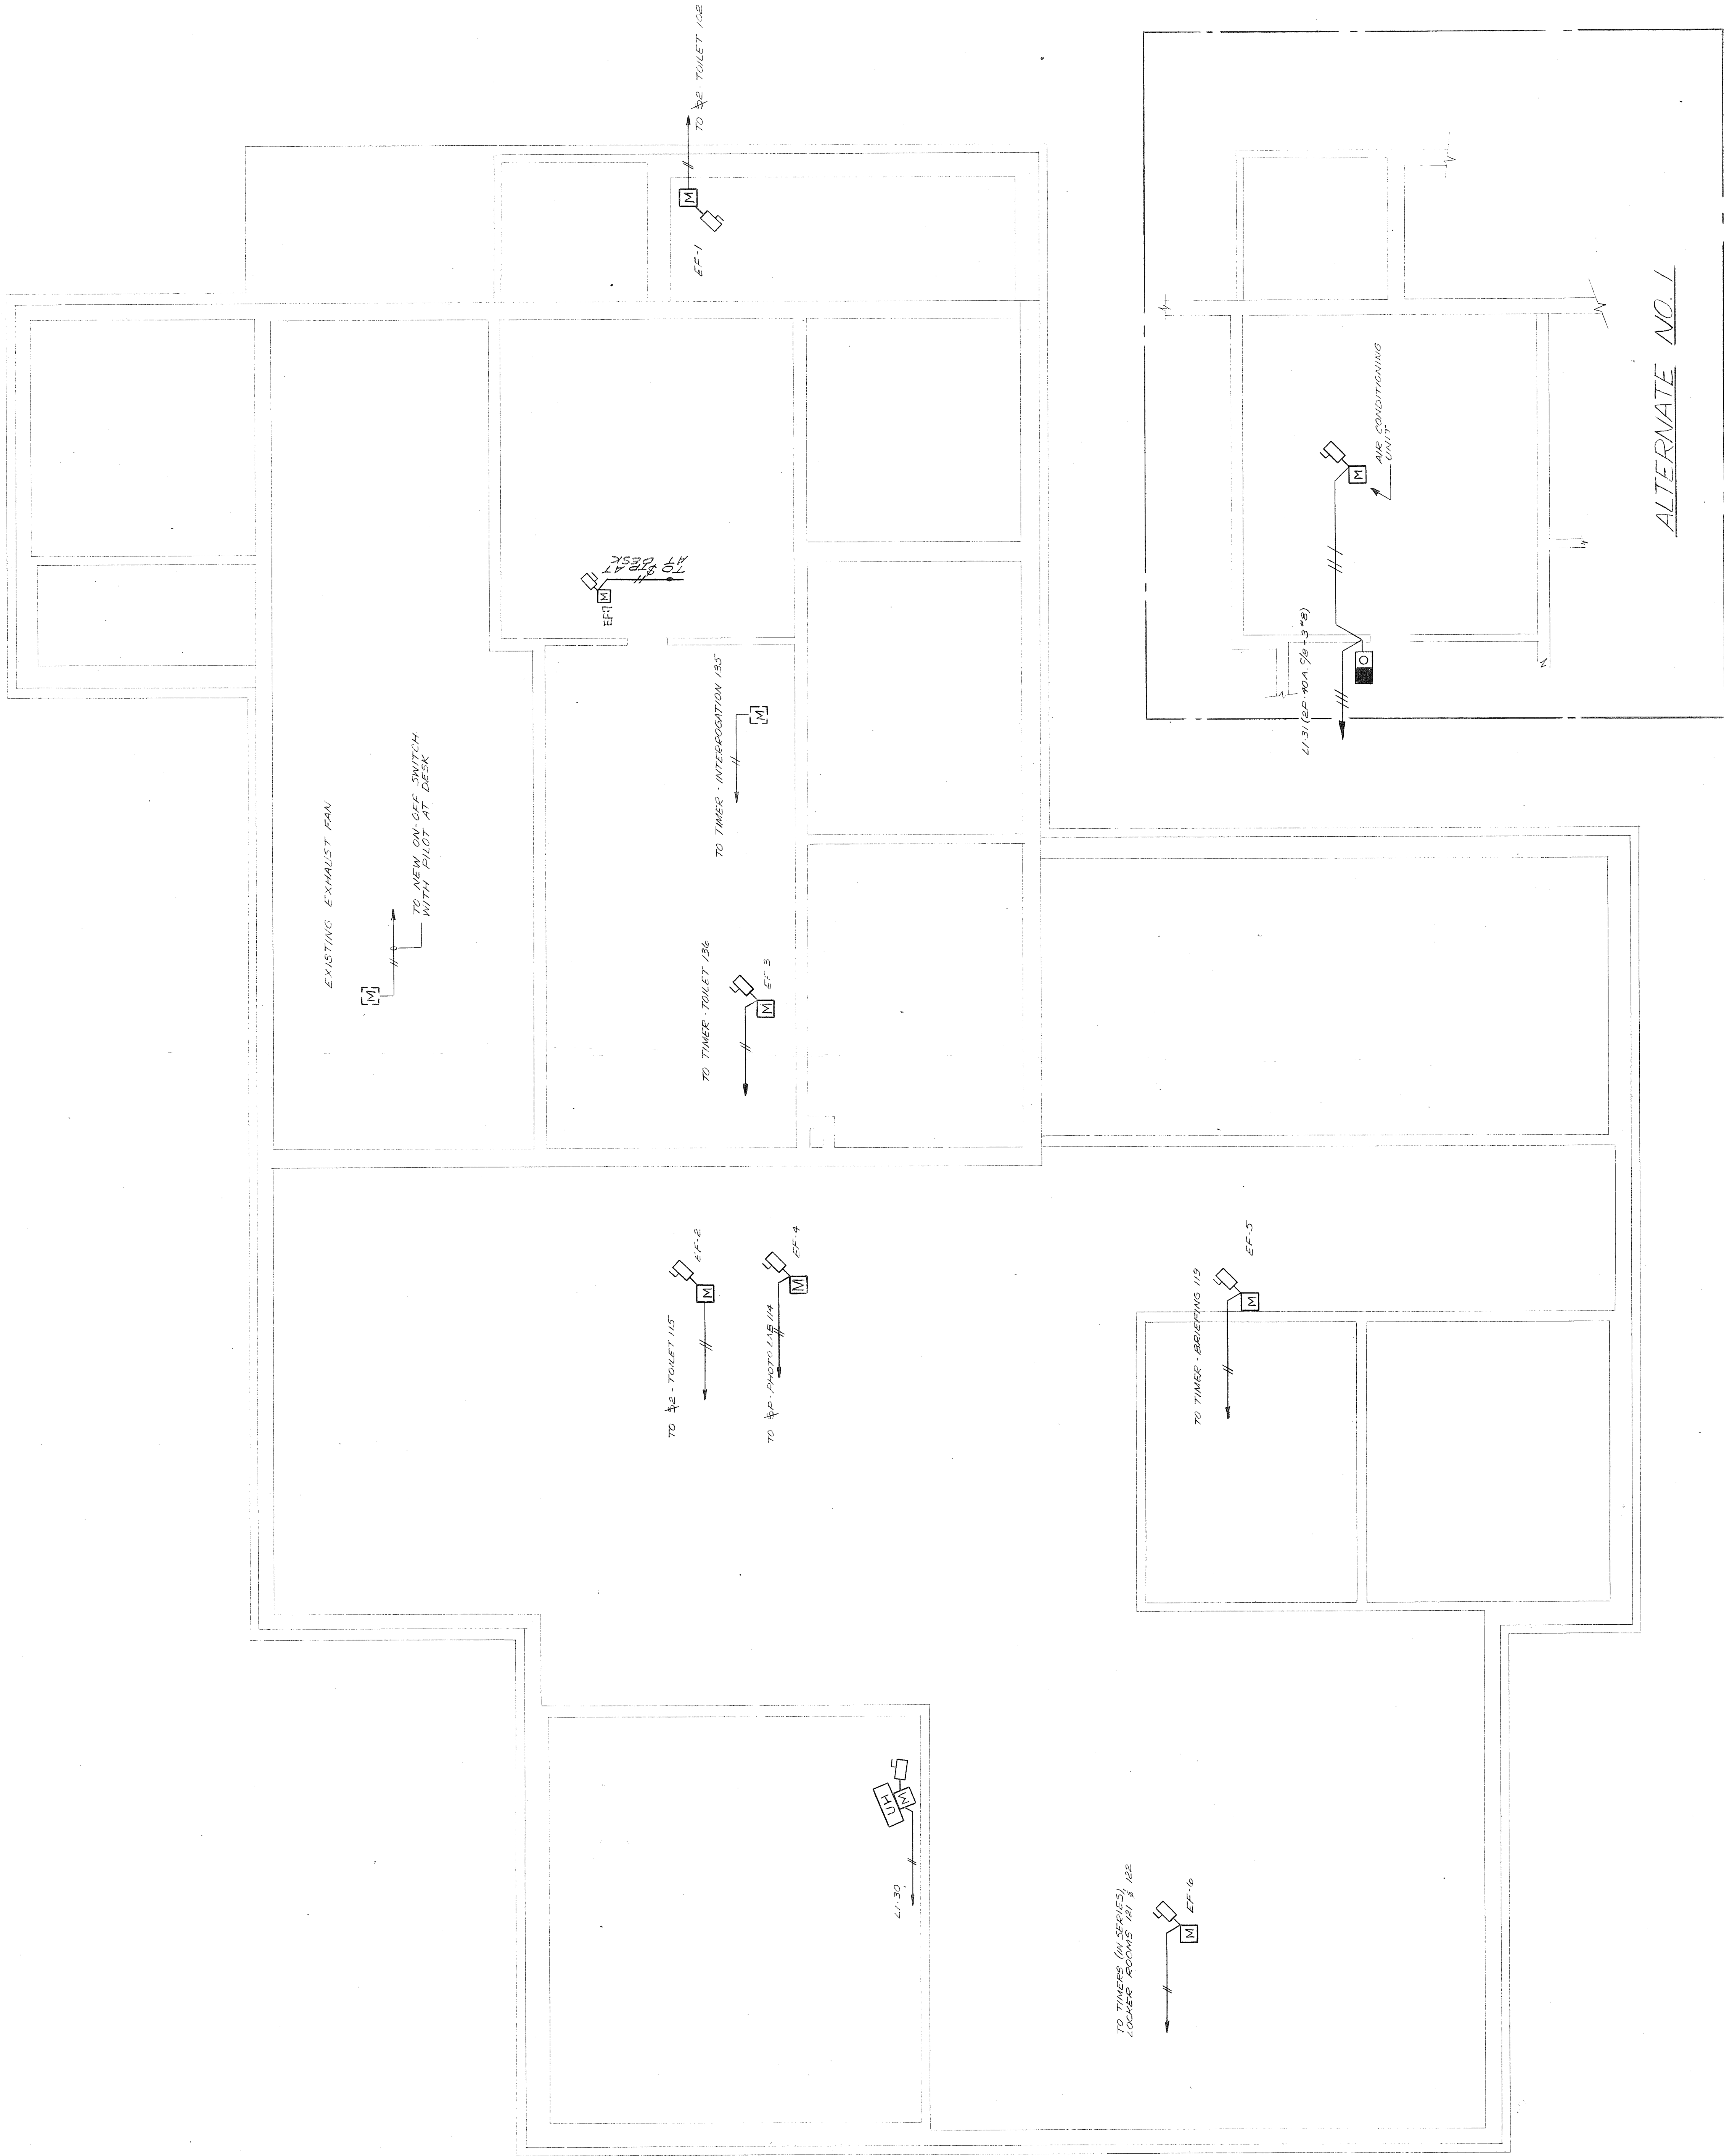

REV. NO. DESCRIPTION DATE BY

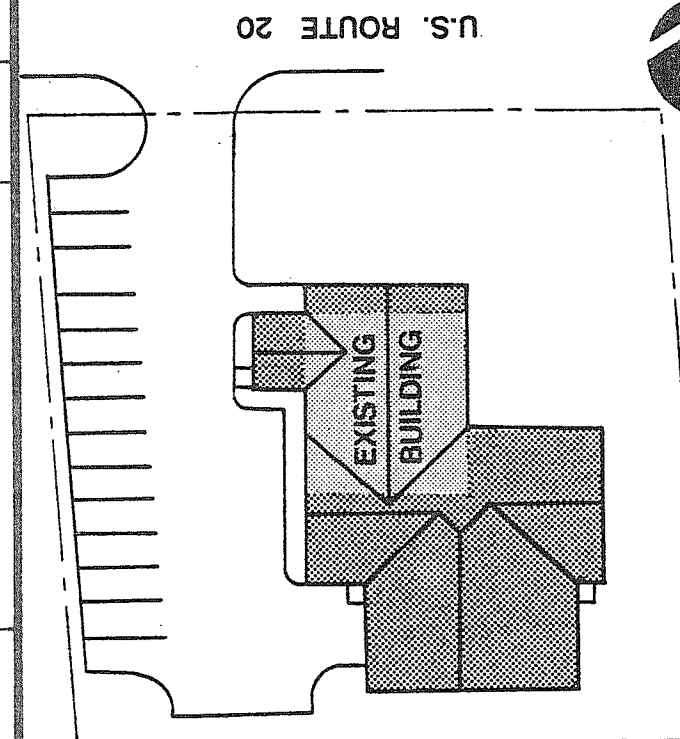

KEY PLAN

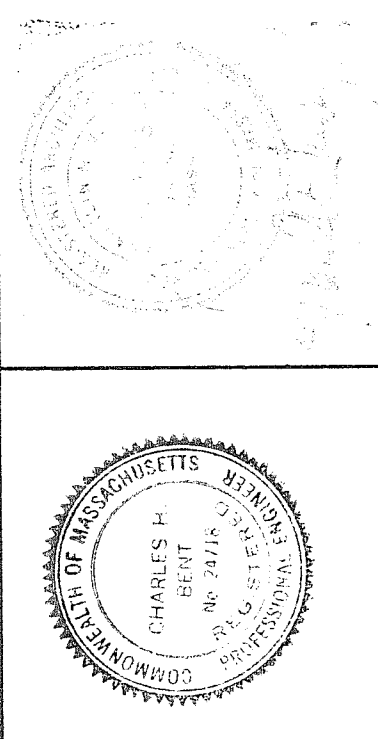

ALTERATIONS & ADDITIONS
POLICE STATION
SUDBURY, MASS.

KUBITZ & PEPI
ARCHITECTS, INC.
66 CENTRAL STREET, WELLESLEY, MASS.

ATTIC LEVEL PLAN

SCALE 1/4" = 1'-0"

DATE AUG. 28, 1980

DR BY J.M.P.C.

CH BY C.H.P.

SHEET 26 OF 35

E-4